




1 EAST ELEVATION
A-2 1/4\" = 1'-0"

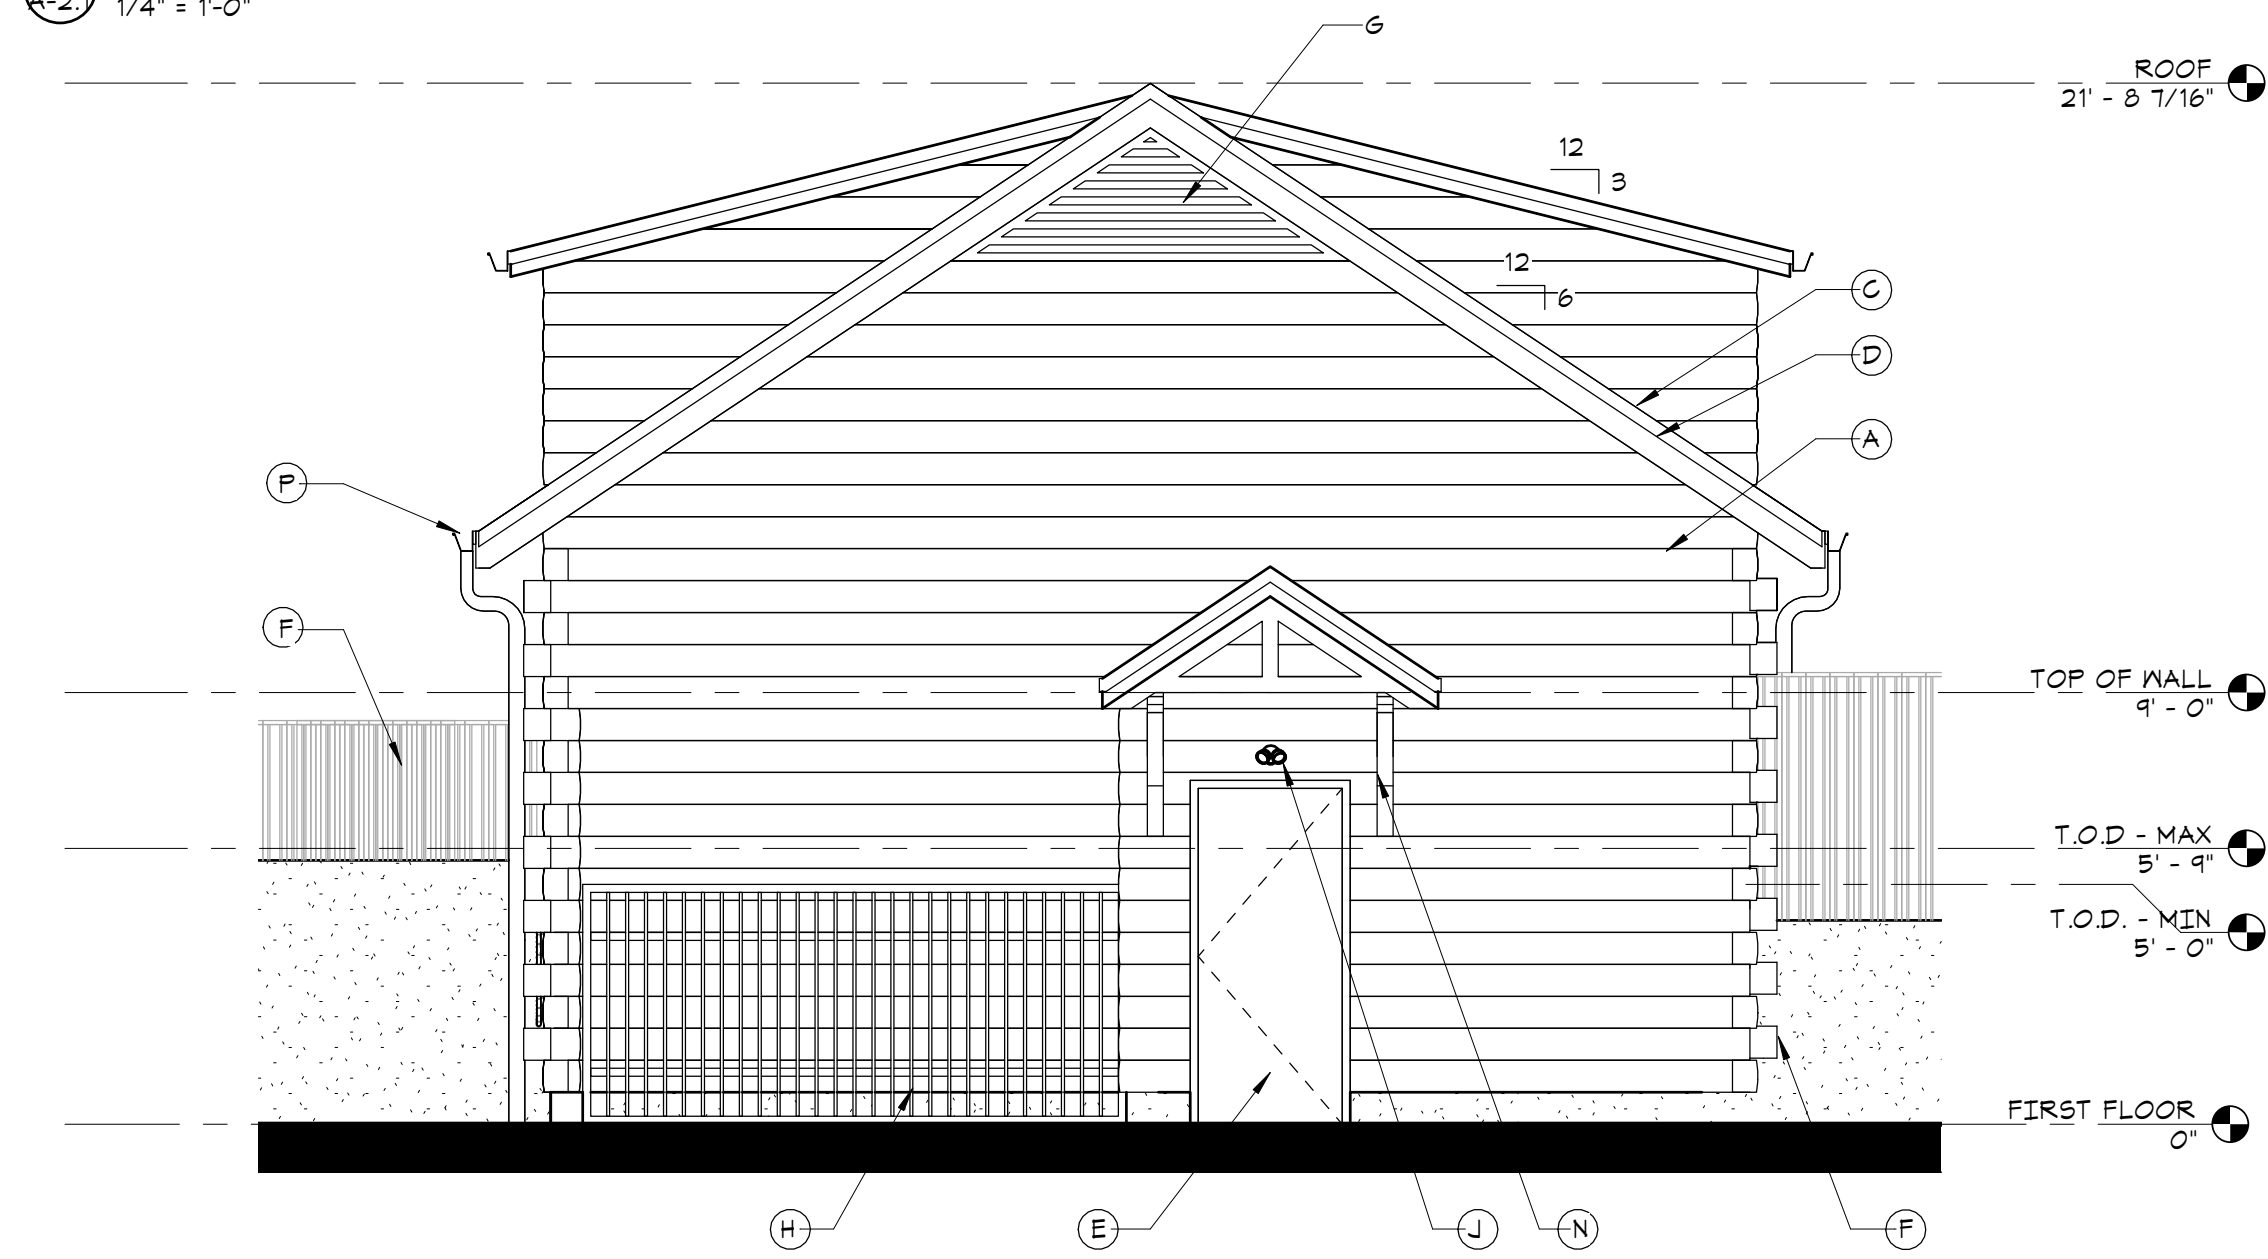


4 WEST ELEVATION
A-2 1/4\" = 1'-0"

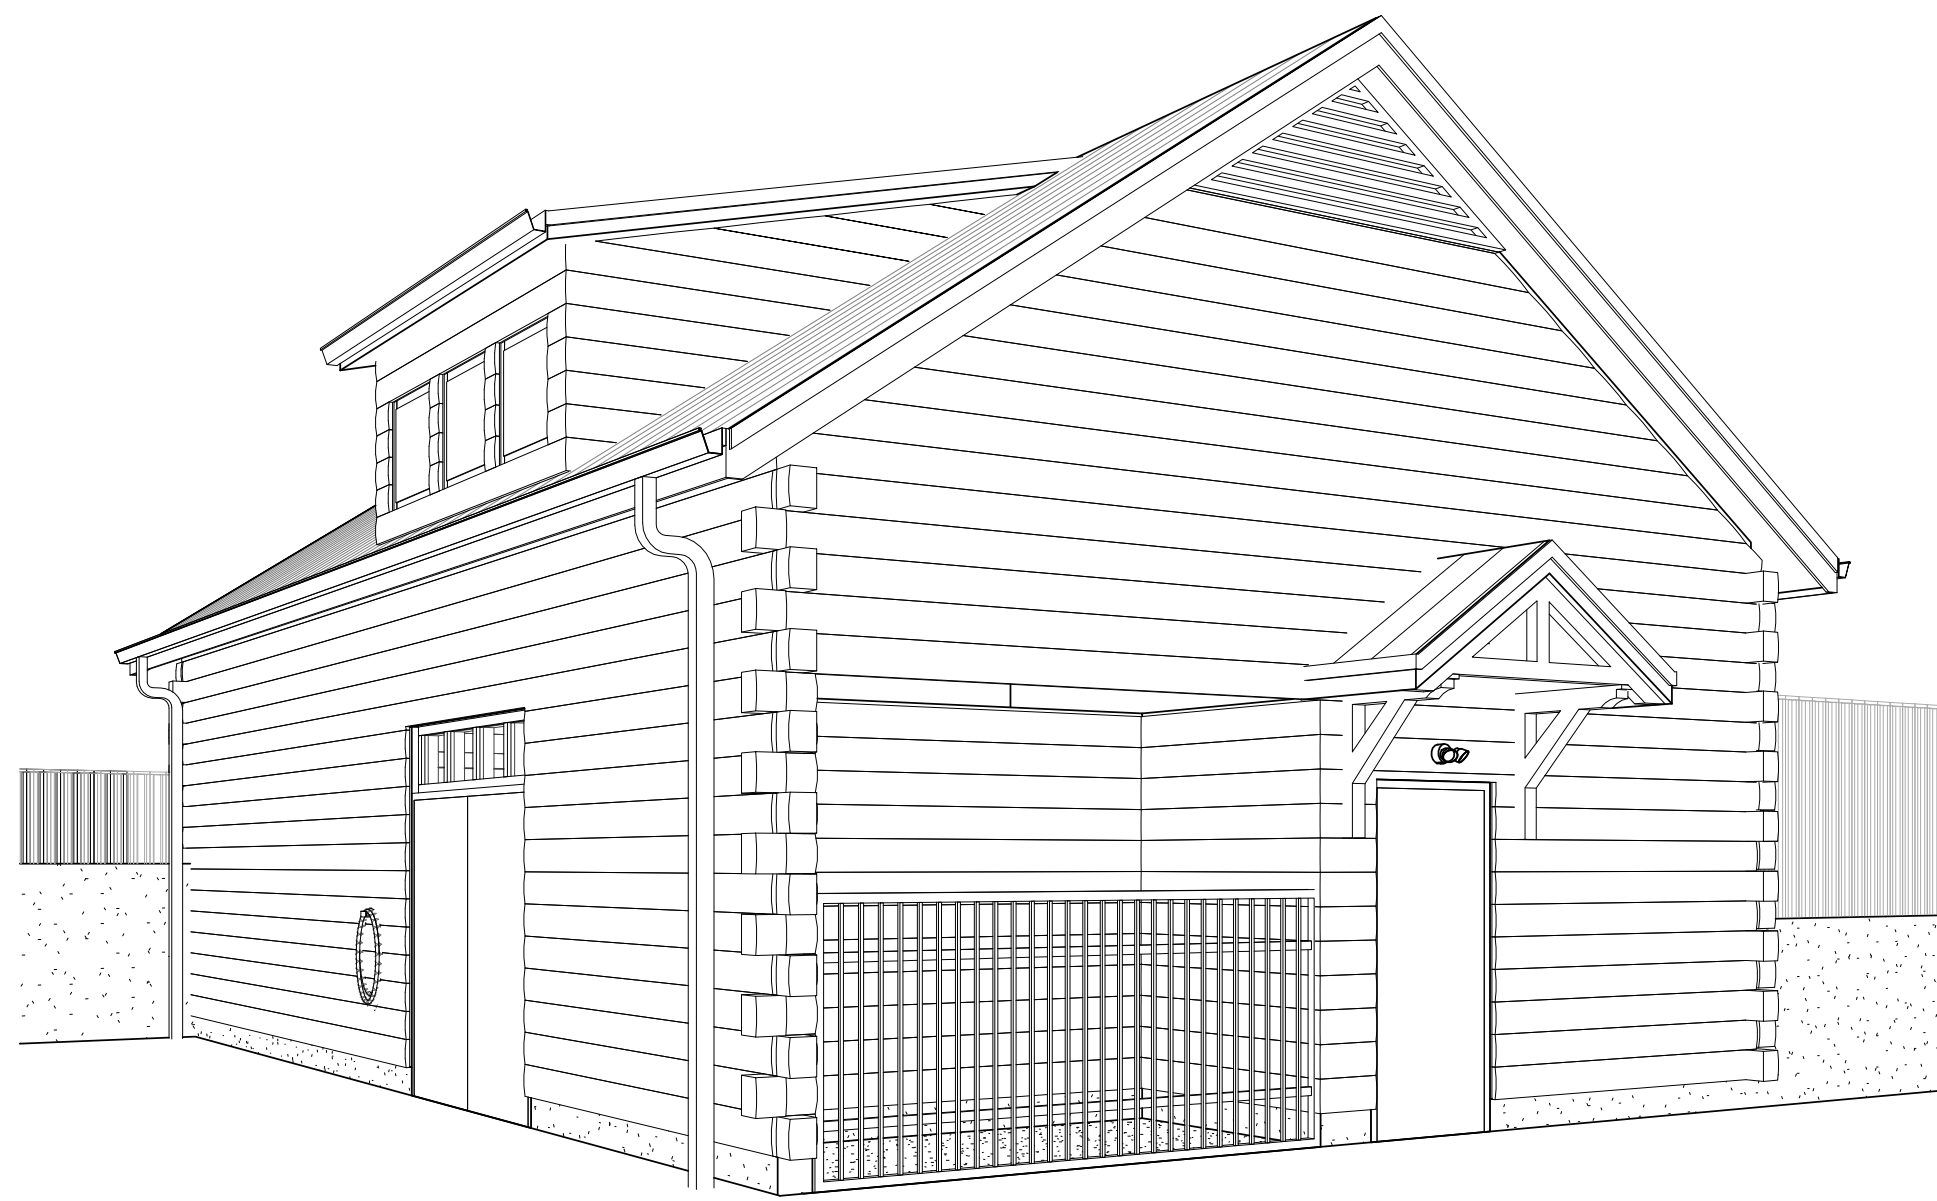


5 3D View 1
A-2 1/4\" = 1'-0"

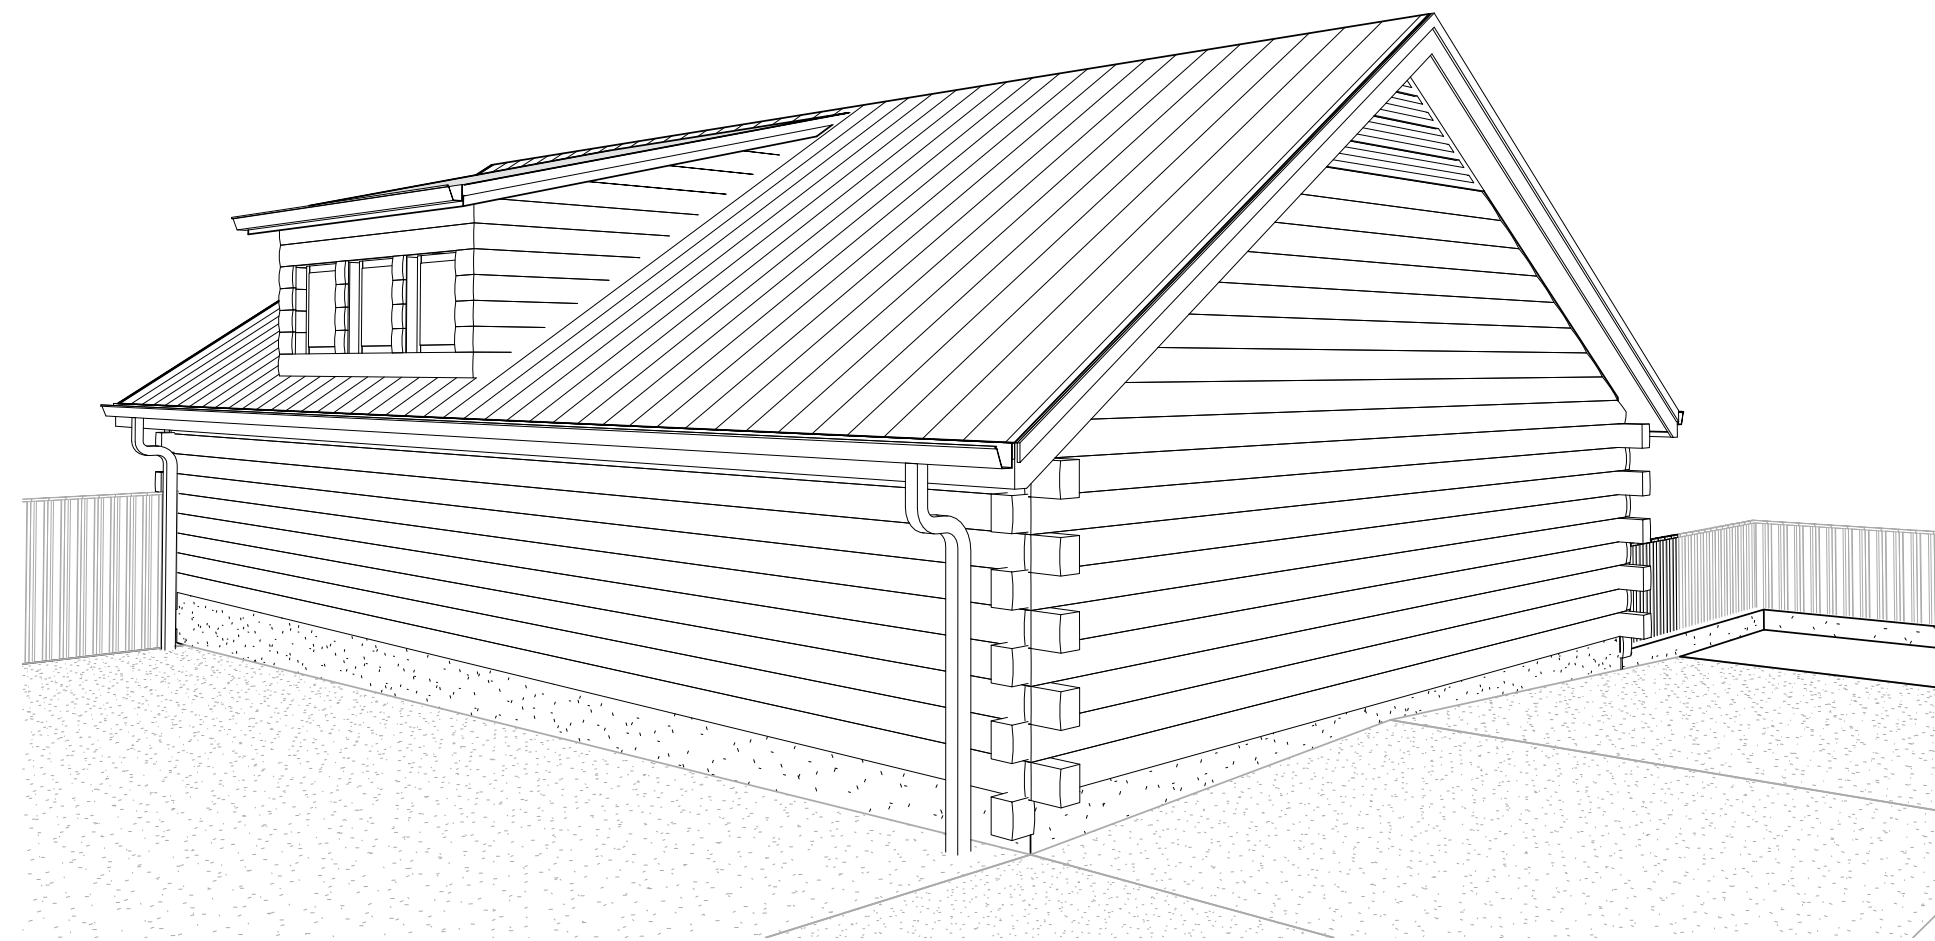

6 3D View 2
A-2 1/4\" = 1'-0"

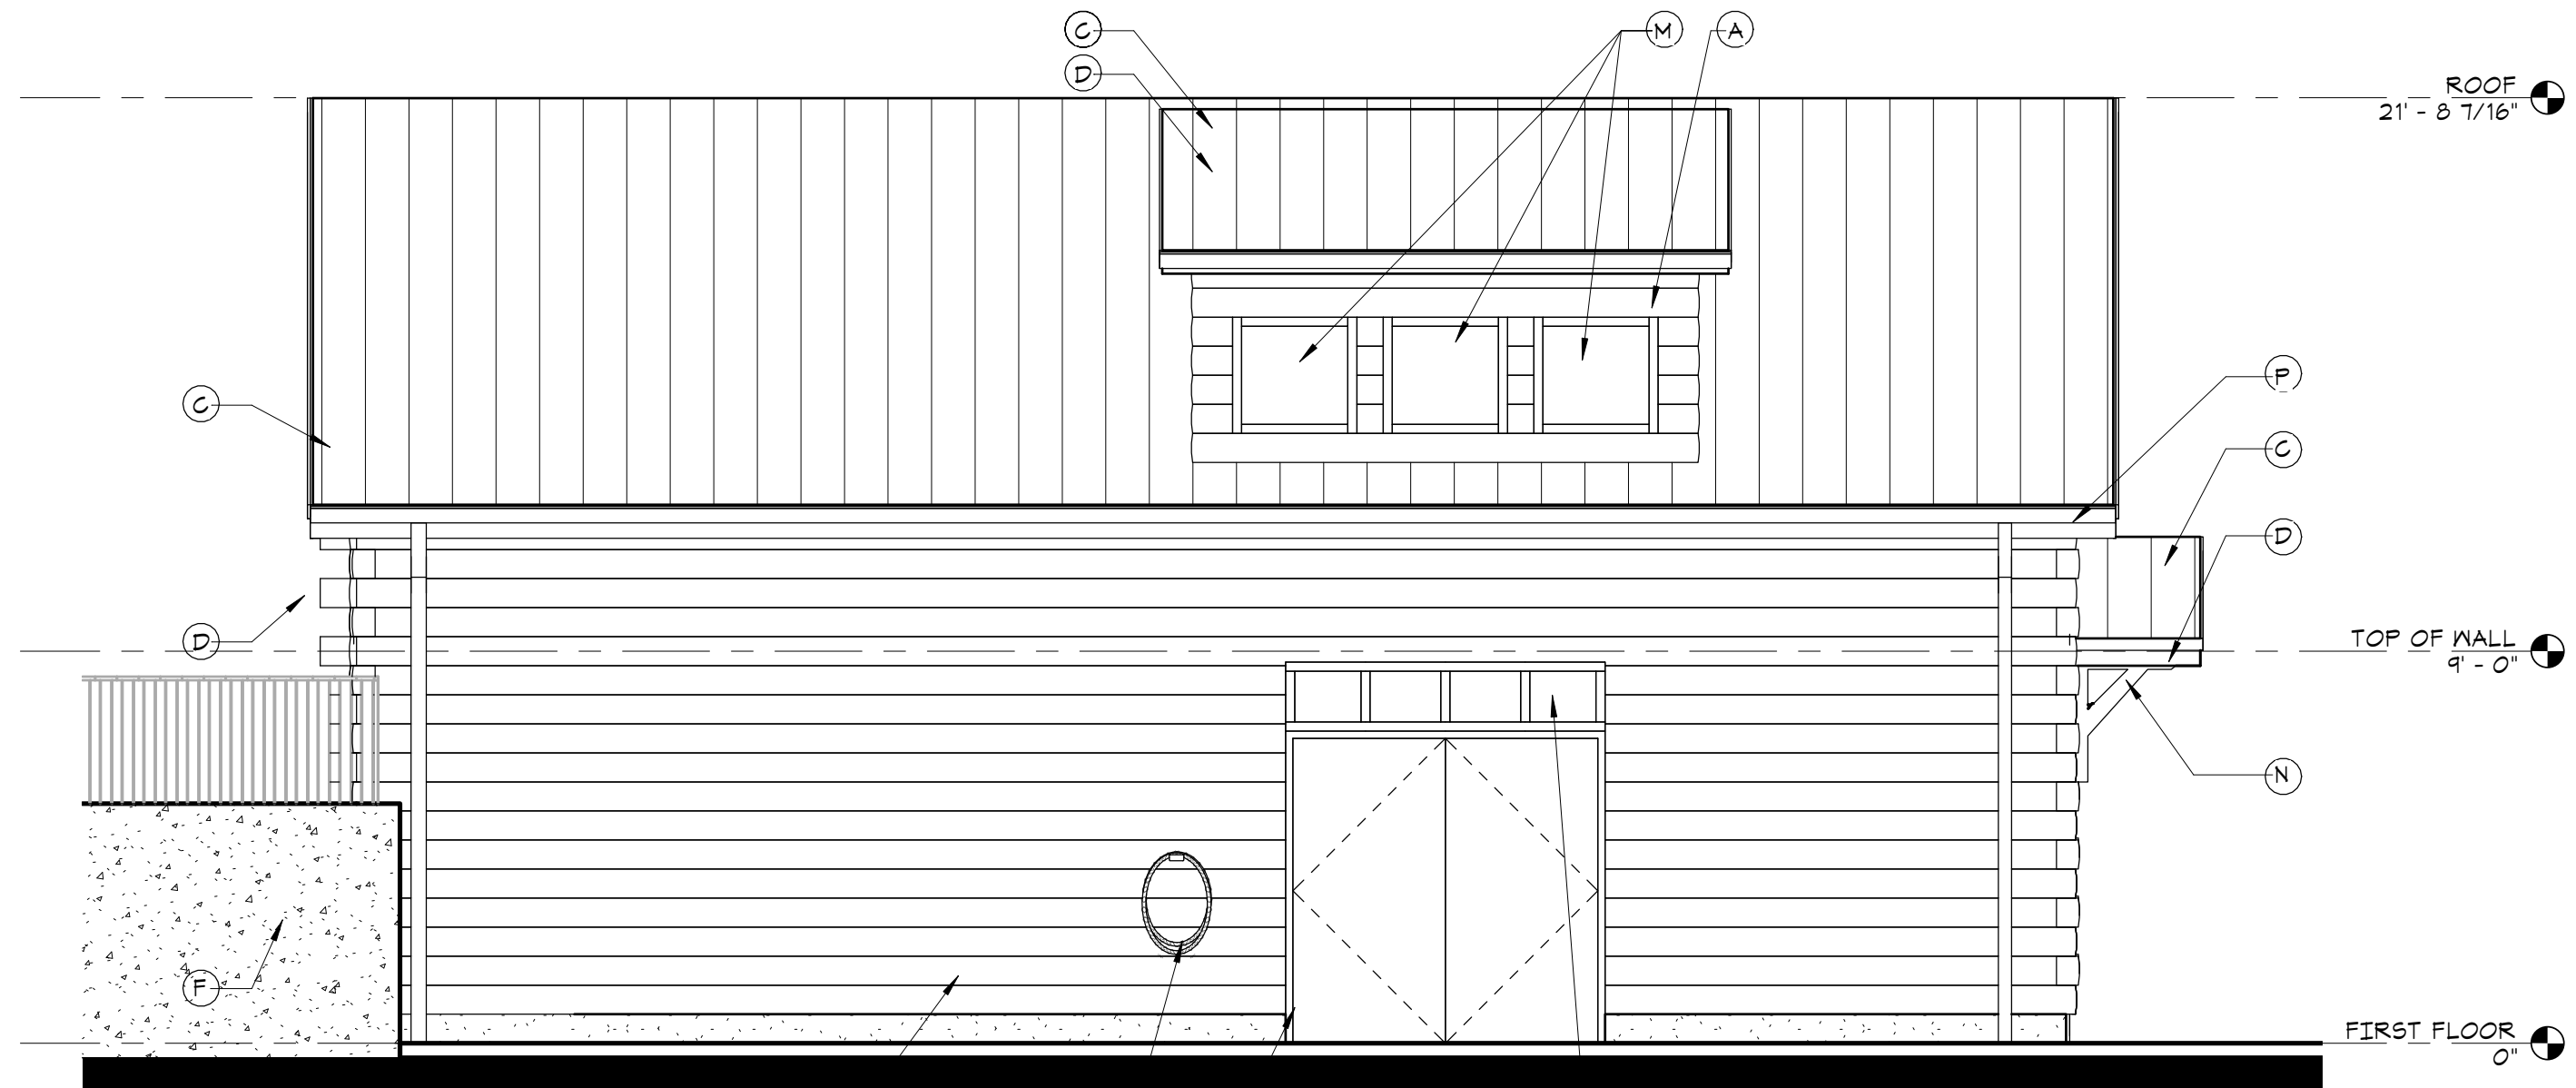

2 NORTH ELEVATION
A-2 1/4\" = 1'-0"

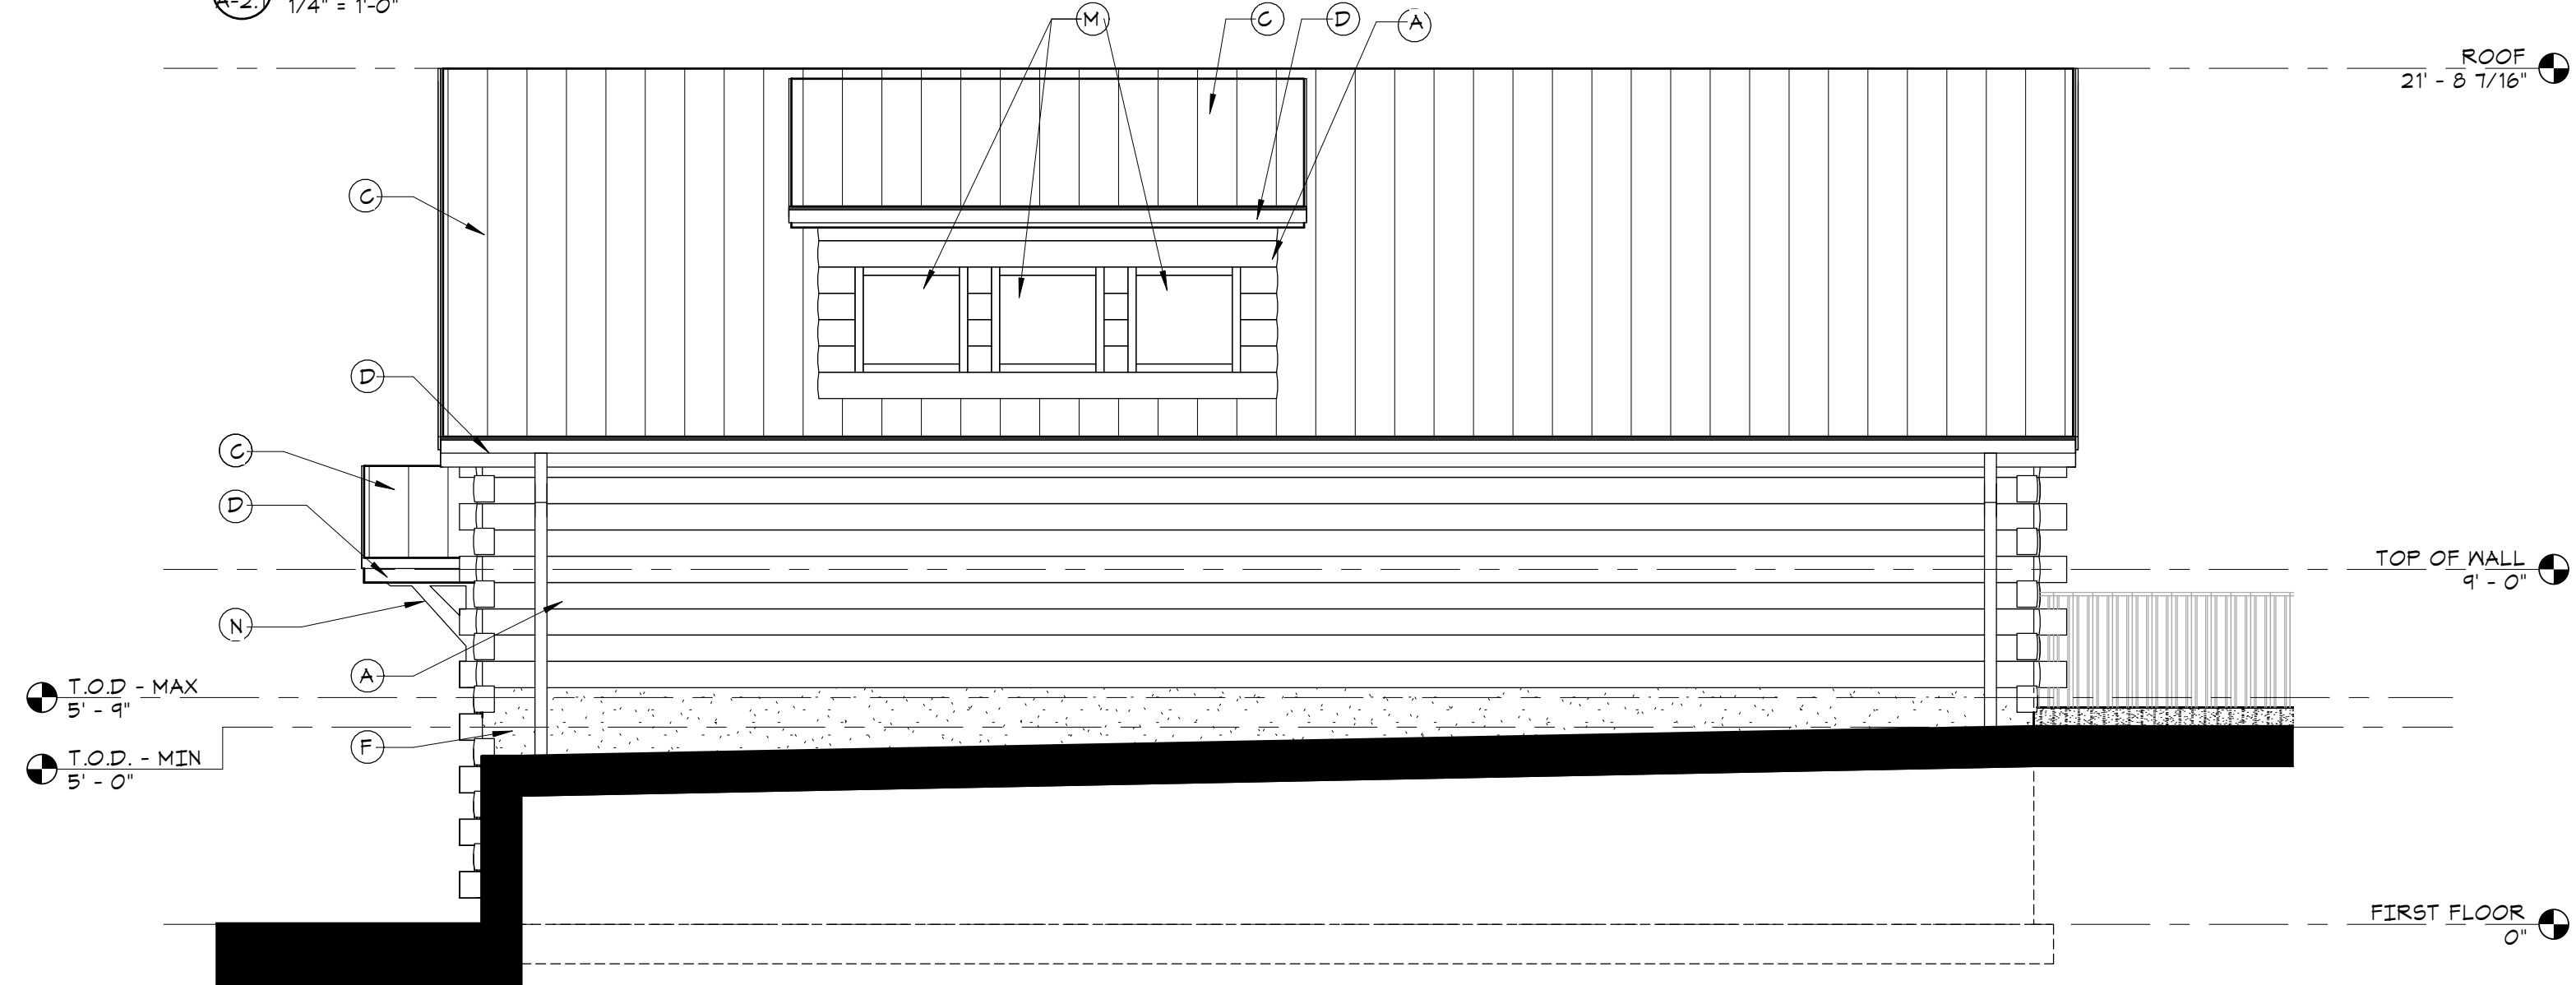

3 SOUTH ELEVATION
A-2 1/4\" = 1'-0"

MATERIAL LEGEND			
TAG	MATERIAL	FINISH	COMMENTS
(A)	FAUX LOG CABIN SIDING	COLOR - TBD BY OWNER	MANUFACTURER/COLOR- BY OWNER; MATCH EXISTING
(B)	CEDAR PANEL FENCE	COLOR - TBD BY OWNER	6\" x 6\" CEDAR WOOD POSTS. PVC/WOOD PANEL GATE/FENCE DOUBLE 4\" GATE WITH DROP PINS.
(C)	STANDING SEAM METAL ROOF	COLOR - GREEN	MANUFACTURER/COLOR- BY OWNER; MATCH EXISTING
(D)	AZEK FASCIA + SHADOW BOARD	COLOR - GREEN	MATCH TO ROOF
(E)	HOLLOW METAL EXTERIOR DOOR	COLOR - WHITE	DOOR MANUFACTURER ANDERSON OR EQUAL
(F)	EXPOSED CONCRETE WALL	COLOR - TBD BY OWNER	MANUFACTURER/COLOR- BY OWNER
(G)	LOUVER VENT	COLOR - GREEN	
(H)	SECURITY GATE	COLOR -BLACK	
(J)	EXTERIOR LIGHTING		MANUFACTURER BY OWNER
(K)	HOSE BIB		SEE PLUMBING PLAN FOR LOCATIONS
(L)	VINYL WINDOWS		MANUFACTURER BY PELLA OR EQUAL
(M)	SPANDRAL WINDOWS		MANUFACTURER BY PELLA OR EQUAL
(N)	ARCHITECTURAL BRACKET	WOOD STAIN TO MATCH SIDING	
(P)	GUTTER/DOWNSPOUT SYSTEM	COLOR - GREEN TO MATCH ROOF	



BRUCE
RONAYNE
HAMILTON
ARCHITECTS

ARCHITECTURE
LAND PLANNING
INTERIOR DESIGN
3D VISUALIZATION

833 TURNPIKE ROAD
P.O. BOX 104
NEW IPSWICH
NEW HAMPSHIRE 03071

THIS DESIGN AND THE DRAWINGS THEREFORE, PREPARED FOR THIS PROJECT, ARE THE PROPERTY OF THE ARCHITECT, BRUCE RONAYNE HAMILTON ARCHITECTS INC., AND THE DESIGN AND/OR DRAWINGS MAY NOT BE USED IN WHOLE OR IN PART FOR ANY USE OTHER THAN FOR THE ORIGINAL PROJECT FOR WHICH THE DESIGN AND/OR DRAWINGS WERE PREPARED, WITHOUT THE EXPRESSED WRITTEN PERMISSION OF THE ARCHITECT, BRUCE RONAYNE HAMILTON ARCHITECTS, INC. NO BUILDING PERMIT SHALL BE ISSUED BY ANY BUILDING DEPARTMENT UNLESS THIS DOCUMENT BEARS THE ORIGINAL SEAL AND SIGNATURE OF THE ARCHITECT, BRUCE RONAYNE HAMILTON ARCHITECTS INC.


PROJECT: ADG POOL FILTER BUILDING
CARVER, MA 02330
SUBJECT: ALTERNATE EXTERIOR ELEVATIONS

JOB NO. 2294
SCALE: 1/4\" = 1'-0\"
DATE: 09/27/2022
DRAWN BY: SS/BB

A-2.1

8 7 6 5 4 3 2 1

F
E
D
C
B
A

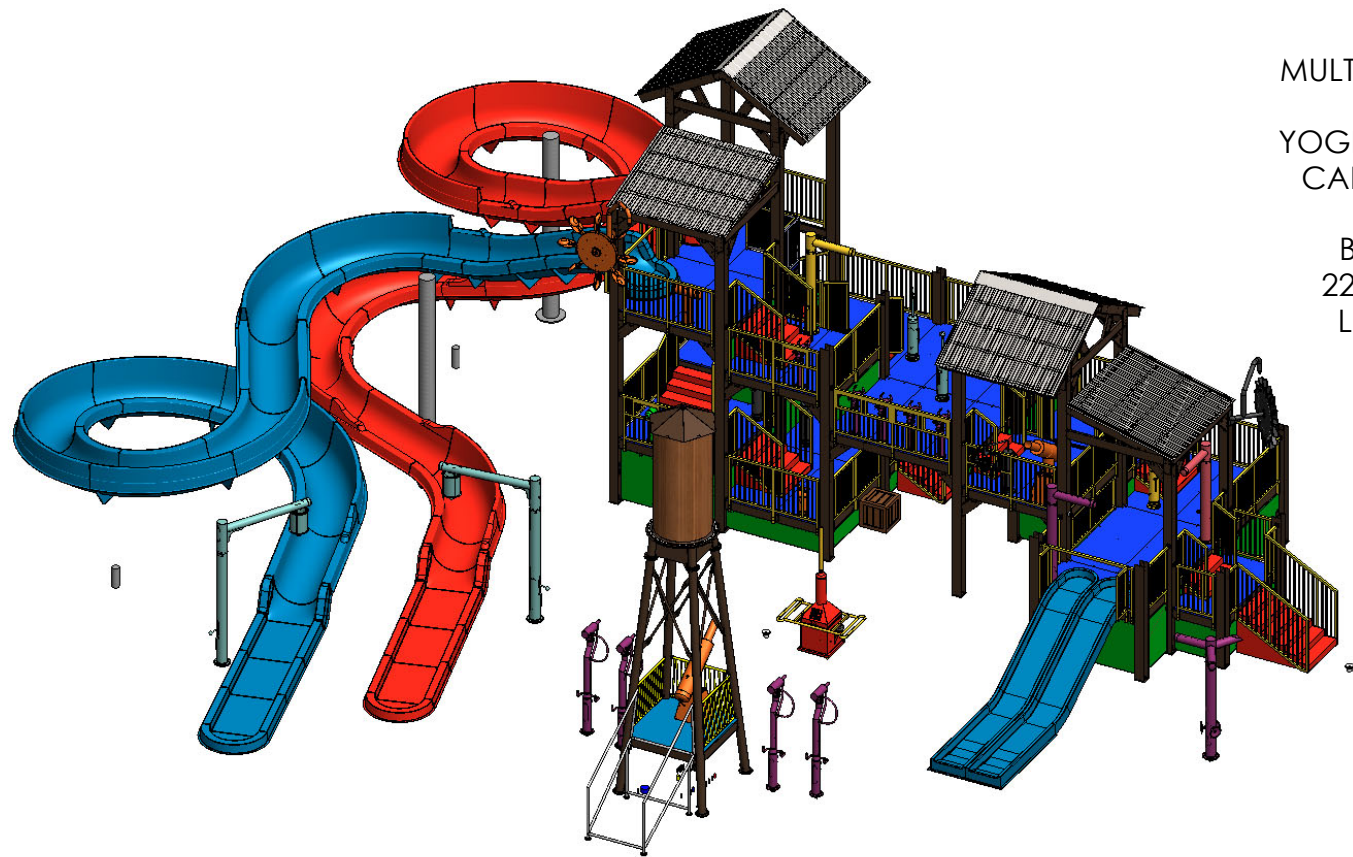


EXCEL SERIES 2.0
MULTI-LEVEL PLAY STRUCTURE

YOGI BEAR JELLYSTONE PARK
CARVER, MASSACHUSETTS




BY INTERACTIVE PLAY
222 SOUTH NIAGARA ST
LOCKPORT, NY 14094

PROPRIETARY AND CONFIDENTIAL
THE INFORMATION CONTAINED IN THIS
DRAWING IS THE SOLE PROPERTY OF
VIRTUAL POLYMER COMPOUNDS. ANY
REPRODUCTION IN PART OR AS A WHOLE
WITHOUT THE WRITTEN PERMISSION OF
VIRTUAL POLYMER COMPOUNDS IS
PROHIBITED.

		UNLESS OTHERWISE SPECIFIED:	NAME		DATE		<div>INTERACTIVEPLAY</div> <div>TITLE:</div> <div>MLPS SUBMITTAL CARVER</div>				
		DIMENSIONS ARE IN INCHES	DRAWN		CD					3/8/2022	
		TOLERANCES:	CHECKED		----						
		FRACTIONAL ±	ENG APPR.		----						
		ANGULAR: MACH ± BEND ±	MFG APPR.		----						
		TWO PLACE DECIMAL ±	Q.A.		----						
		THREE PLACE DECIMAL ±	COMMENTS:								
		INTERPRET GEOMETRIC TOLERANCING PER:									
		MATERIAL:									
		FINISH:									
NEXT ASSY		USED ON					SIZE B	DWG. NO. CTST-1000	REV —		
APPLICATION		DO NOT SCALE DRAWING					SCALE:	WEIGHT:	SHEET 1 OF 12		

8 7 6 5 4 3 2 1

F
E
D
C
B
A

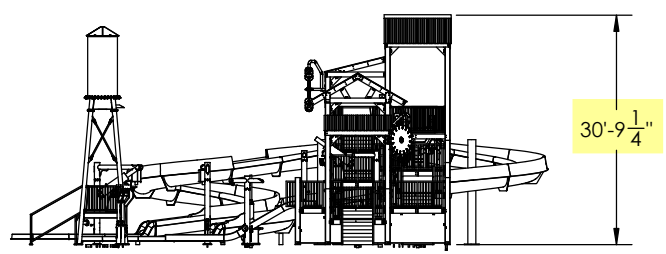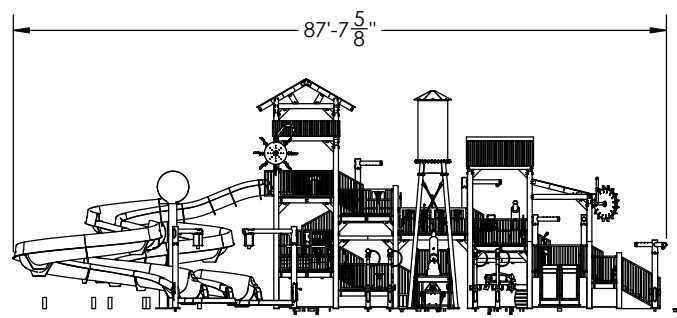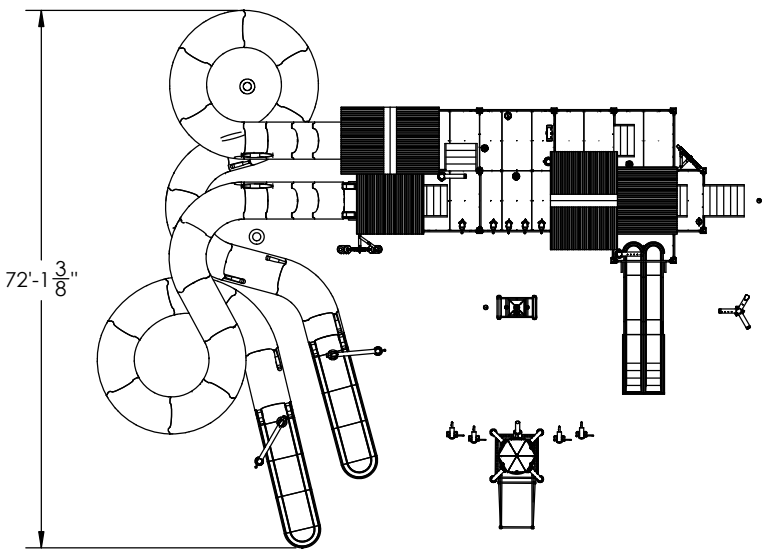


PROPRIETARY AND CONFIDENTIAL
 THE INFORMATION CONTAINED IN THIS
 DRAWING IS THE SOLE PROPERTY OF
 VIRTUAL POLYMER COMPOUNDS. ANY
 REPRODUCTION IN PART OR AS A WHOLE
 WITHOUT THE WRITTEN PERMISSION OF
 VIRTUAL POLYMER COMPOUNDS IS
 PROHIBITED.

		UNLESS OTHERWISE SPECIFIED:		NAME	DATE
		DIMENSIONS ARE IN INCHES	DRAWN	CD	3/8/2022
		TOLERANCES:	CHECKED	---	---
		FRACTIONAL ±	ENG APPR.	---	---
		ANGULAR: MACH ± BEND ±	MFG APPR.	---	---
		TWO PLACE DECIMAL ±	Q.A.	---	---
		THREE PLACE DECIMAL ±	COMMENTS:		
		INTERPRET GEOMETRIC			
		TOLERANCING PER:			
		MATERIAL:			
		FINISH:			
		-			
NEXT ASSY	USED ON	-			
APPLICATION		DO NOT SCALE DRAWING			




TITLE:
**MLPS SUBMITTAL
 CARVER
 OVERALL DIMENSIONS**

SIZE B	DWG. NO. CTST-1000	REV -
SCALE:	WEIGHT:	SHEET 3 OF 12

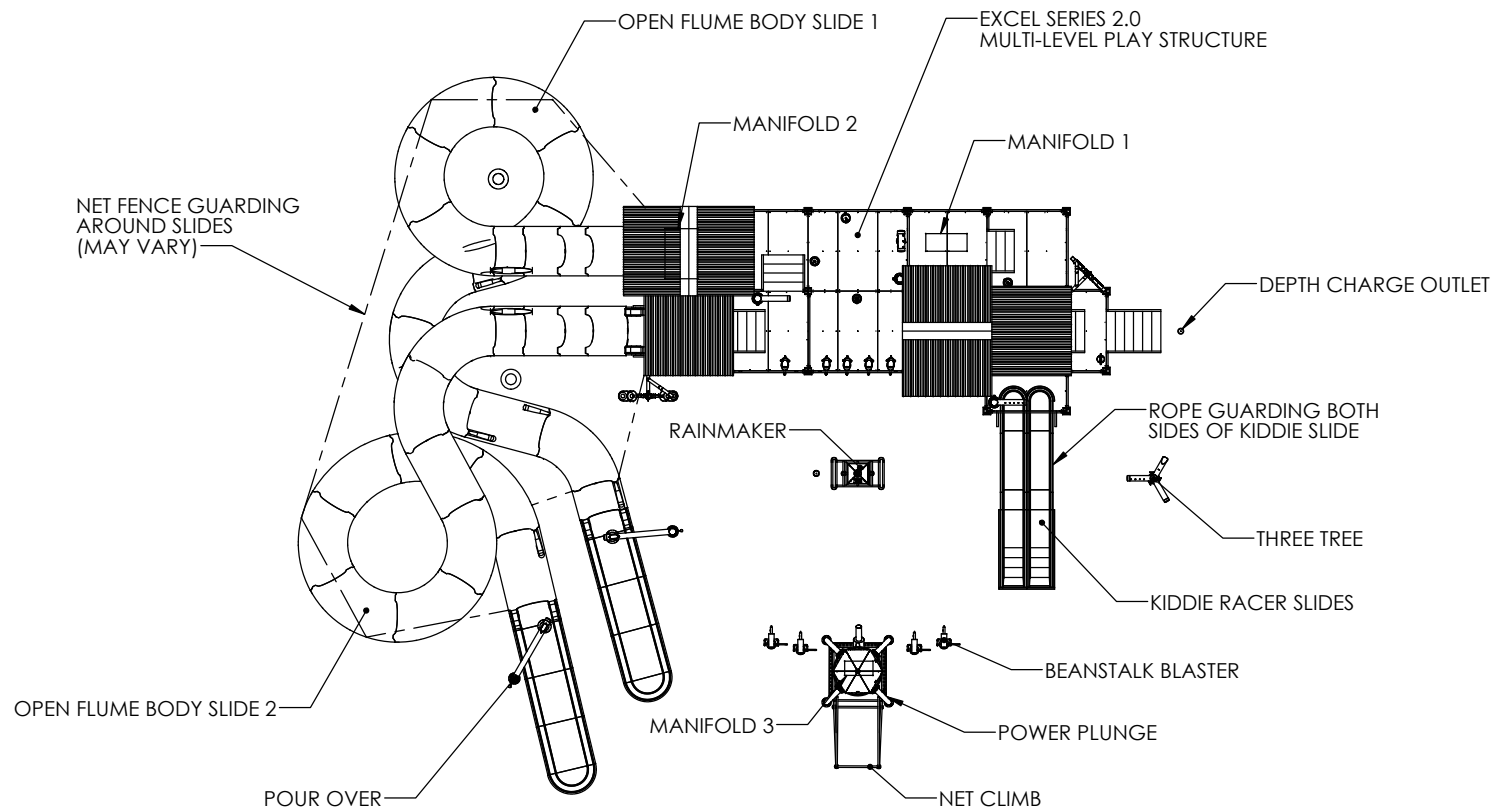

PROPRIETARY AND CONFIDENTIAL
THE INFORMATION CONTAINED IN THIS DRAWING IS THE SOLE PROPERTY OF VIRTUAL POLYMER COMPOUNDS. ANY REPRODUCTION IN PART OR AS A WHOLE WITHOUT THE WRITTEN PERMISSION OF VIRTUAL POLYMER COMPOUNDS IS PROHIBITED.

		UNLESS OTHERWISE SPECIFIED:	NAME		DATE			
		DIMENSIONS ARE IN INCHES	DRAWN	CD	3/8/2022			
		TOLERANCES:	CHECKED	----	----			
		FRACTIONAL ±	ENG APPR.	----	----			
		ANGULAR: MACH ± BEND ±	MFG APPR.	----	----			
		TWO PLACE DECIMAL ±	Q.A.		----	TITLE: MLPS SUBMITTAL CARVER GENERAL INFO		
		THREE PLACE DECIMAL ±	COMMENTS:					
		INTERPRET GEOMETRIC TOLERANCING PER:						
		MATERIAL:						
		FINISH:						
NEXT ASSY		USED ON				SIZE B	DWG. NO. CTST-1000	REV -
APPLICATION		DO NOT SCALE DRAWING				SCALE:	WEIGHT:	SHEET 4 OF 12